


POWER

SYMBOL	DESCRIPTION
[Symbol]	PANEL BOARD
[Symbol]	SUB DISTRIBUTION BOARD
[Symbol]	ISOLATOR SWITCH
[Symbol]	SWITCH FUSE DISCONNECTOR (X DENOTES RATING / SINGLE OR 3 PHASE)
[Symbol]	TWIN SWITCHED SOCKET OUTLET (SSO)
[Symbol]	SWITCHED SOCKET OUTLET
[Symbol]	UNSWITCHED SOCKET OUTLET
[Symbol]	SWITCHED FUSED CONNECTION UNIT
[Symbol]	UNSWITCHED FUSED CONNECTION UNIT
[Symbol]	FLEX OUTLET
[Symbol]	KEY SWITCHED FUSED CONNECTION UNIT
[Symbol]	DENOTES NEGN INDICATED
[Symbol]	DENOTES COMPLETE WITH FLEX OUTLET
[Symbol]	SHOWER SOCKET
[Symbol]	DOUBLE POLE SWITCH (X DENOTES RATING IN AMP)
[Symbol]	3 POLE ISOLATOR SWITCH
[Symbol]	FLOOR BOX C/W 1X3G 13A SSO, 2G DATA OUTLET - * denotes +SA
[Symbol]	COOKER CONTROL UNIT
[Symbol]	DATA OUTLET
[Symbol]	LUTRON SLAVE PANEL


FIRE ALARM

[Symbol]	DOOR HOLD OPEN UNIT
[Symbol]	FIRE ALARM MAIN PANEL
[Symbol]	FIRE ALARM REPEATER PANEL
[Symbol]	SMOKE DETECTOR
[Symbol]	SMOKE DETECTOR C/W SOUNDER BASE
[Symbol]	SMOKE DETECTOR C/W SOUNDER BASE & ZENON BEACON
[Symbol]	HEAT DETECTOR
[Symbol]	HEAT DETECTOR C/W SOUNDER BASE & ZENON BEACON
[Symbol]	HEAT DETECTOR C/W SOUNDER BASE
[Symbol]	FIRE ALARM MANUAL CALL POINT (BREAK GLASS)
[Symbol]	INTERFACE UNIT
[Symbol]	FIRE ALARM SOUNDER

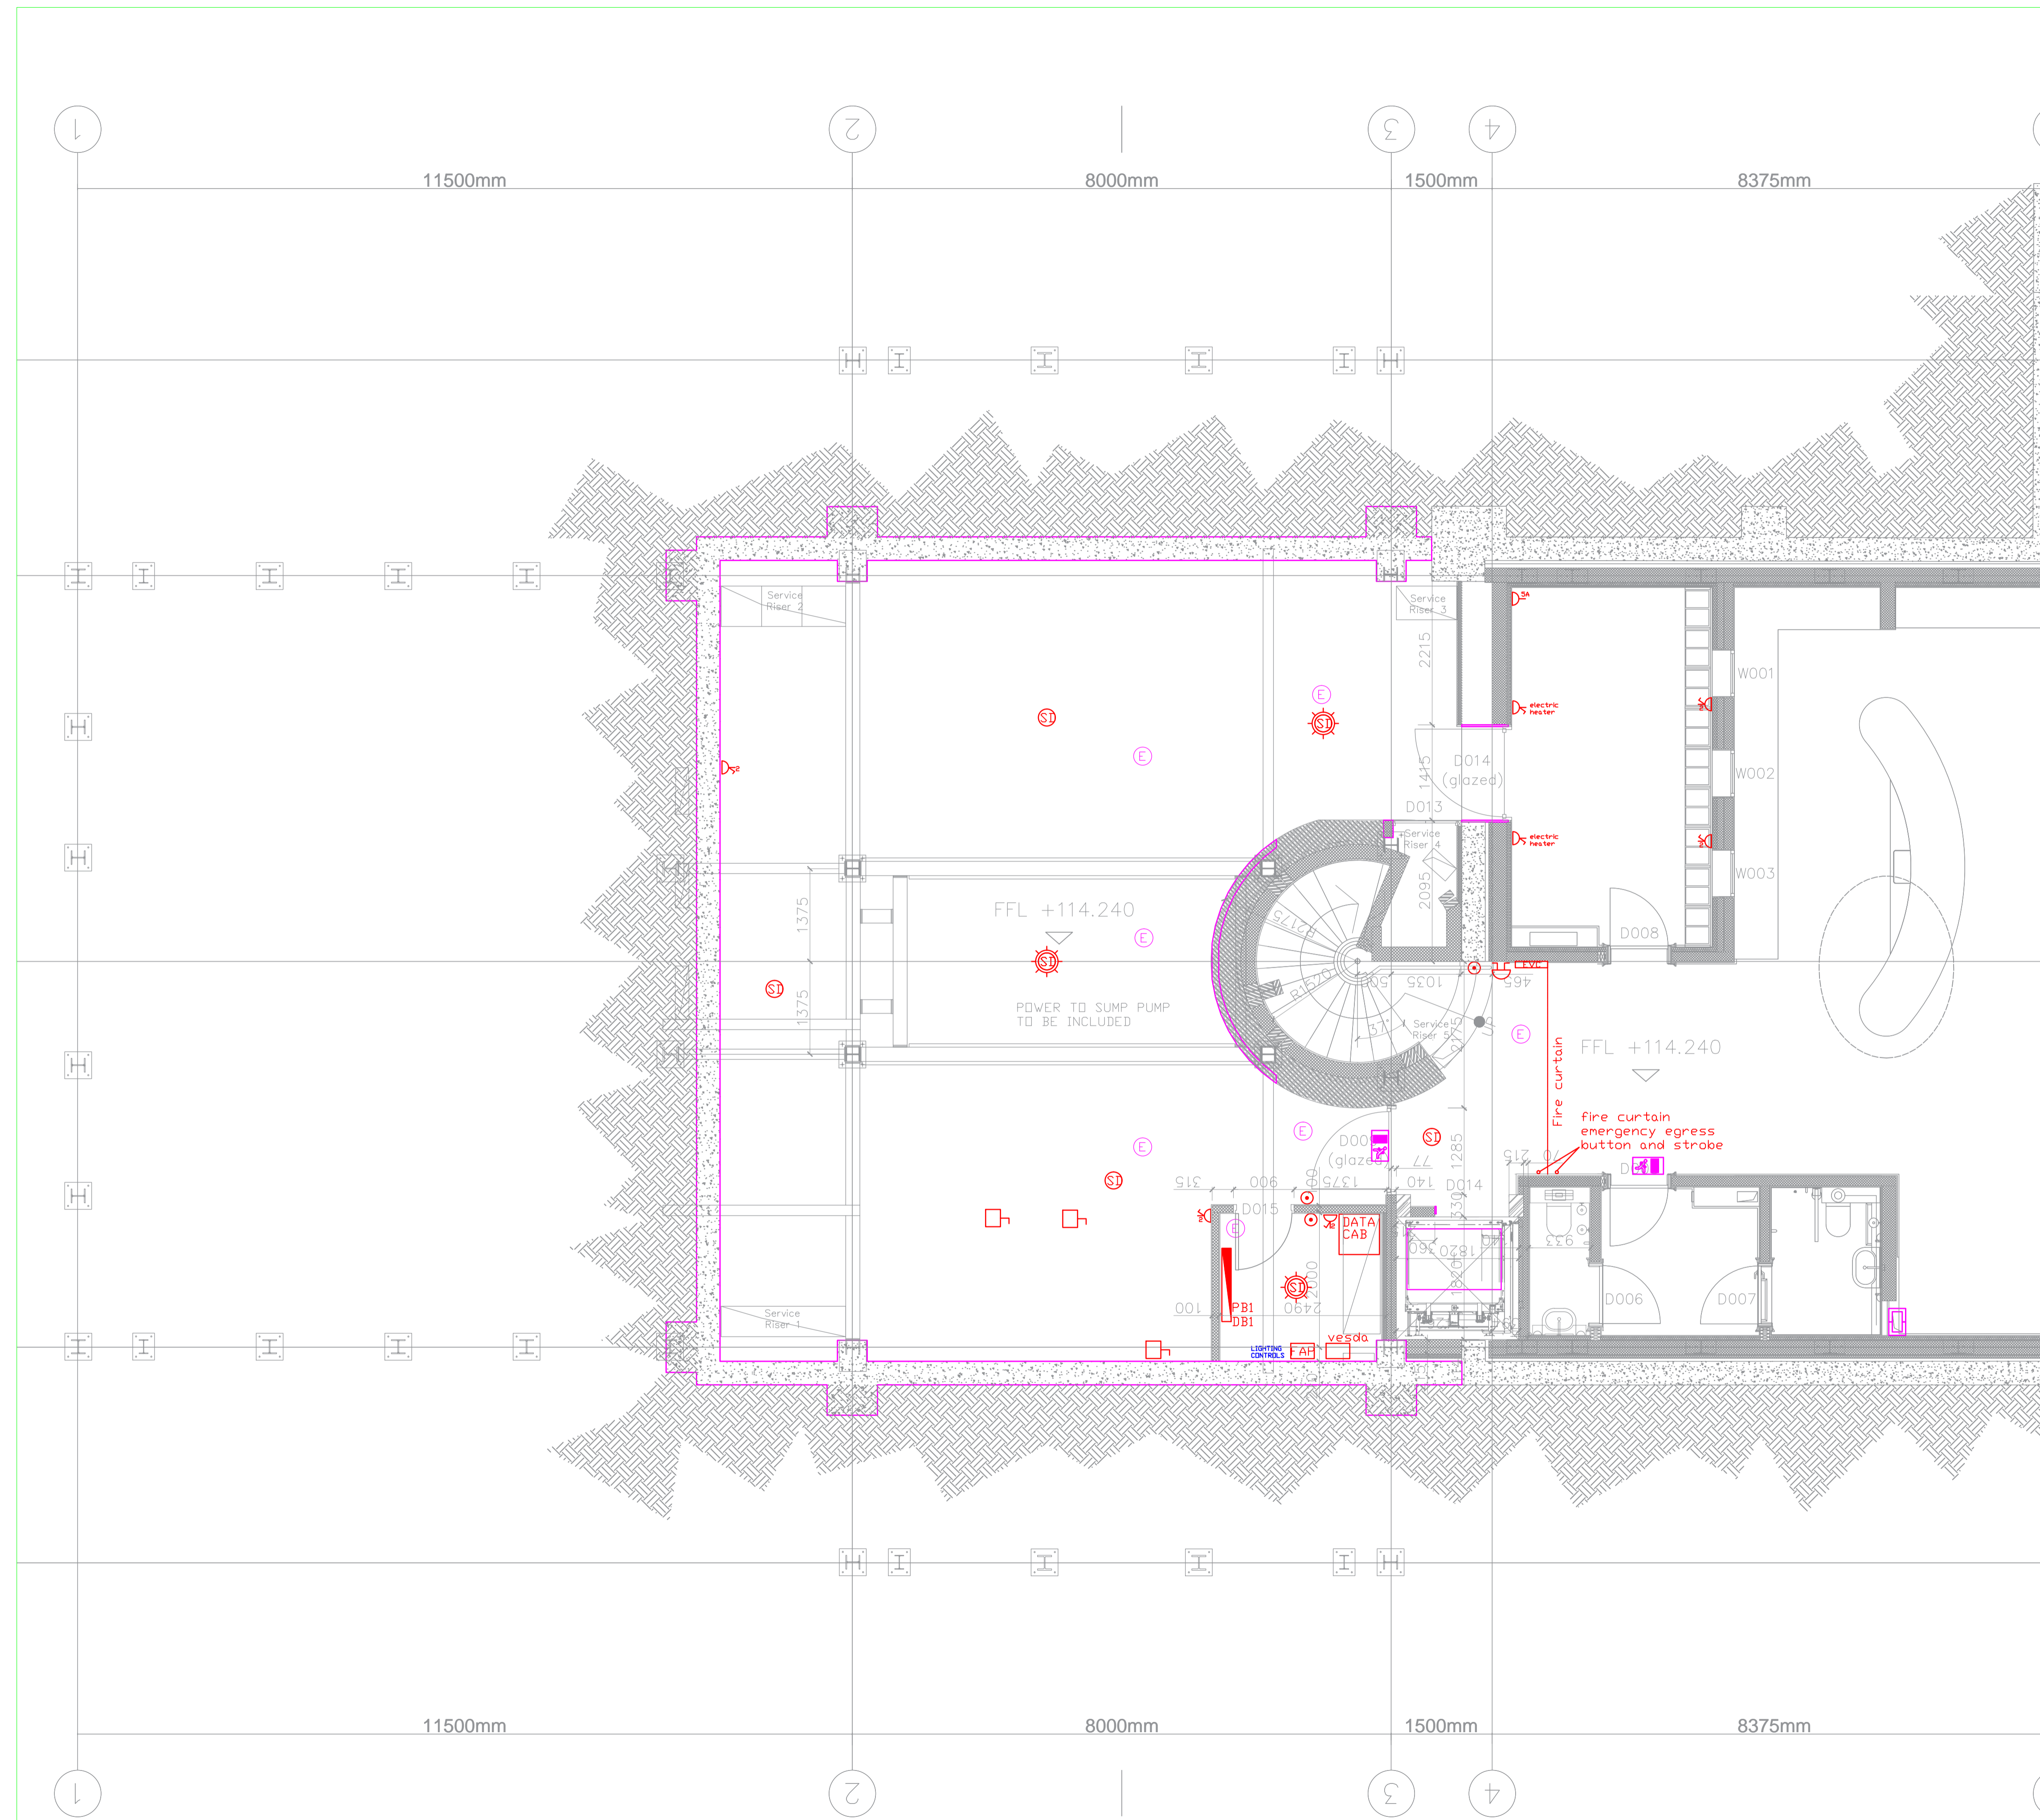

PROJECT Exton Park Vineyard Basingstoke Hampshire	
ARCHITECT Luke Rose Architect	
DWG TITLE Electrical Layout Lower Ground Floor	
REVISIONS	
C	14/7/21 As Filled
B	16/3/2020 Updated to suit Owl lighting & interior designer layout
A	15/1/2020 Updated to suit new building layout
ISSUED C	DATE Dec. 2018
SCALE 35000.1	SCALE 1:50 @ A1
CHECKED [Signature]	JS
Baudelaire Ltd SPECIALISTS IN ELECTRICAL DESIGN & CONTRACTING Unit 7, Prospect Business Centre Prospect Road, Aylesford Hants. SO24 9UH Tel: 01962 737020 Fax: 01962 737022 info@baudelaireltd.co.uk www.baudelaireltd.co.uk Established 1976	


POWER	
SYMBOL	DESCRIPTION
[Symbol]	PANEL BOARD
[Symbol]	SUB DISTRIBUTION BOARD
[Symbol]	ISOLATOR SWITCH
[Symbol]	SWITCH FUSE DISCONNECTOR OR DENOTES RATING / SINGLE DR 3 PHASE
[Symbol]	TVN SWITCHED SOCKET OUTLET - CESSD
[Symbol]	SWITCHED SOCKET OUTLET
[Symbol]	UNSWITCHED SOCKET OUTLET
[Symbol]	SWITCHED FUSED CONNECTION UNIT
[Symbol]	UNSWITCHED FUSED CONNECTION UNIT
[Symbol]	FLEX OUTLET
[Symbol]	KEY SWITCHED FUSED CONNECTION UNIT
[Symbol]	DENOTES NEON INDICATED
[Symbol]	DENOTES COMPLETE WITH FLEX OUTLET
[Symbol]	SHOWER SOCKET
[Symbol]	DOUBLE POLE SWITCH OR DENOTES RATING IN AMP
[Symbol]	3 POLE ISOLATOR SWITCH
[Symbol]	FLOOR BOX C/W 1X3G 13A SSD, 2G DATA OUTLET - * denotes +5A
[Symbol]	COOKER CONTROL UNIT
[Symbol]	DATA OUTLET
[Symbol]	LUTRON SLAVE PANEL
FIRE ALARM	
[Symbol]	DOOR HOLD OPEN UNIT
[Symbol]	FIRE ALARM MAIN PANEL
[Symbol]	FIRE ALARM REPEATER PANEL
[Symbol]	SMOKE DETECTOR
[Symbol]	SMOKE DETECTOR C/W SOUNDER BASE
[Symbol]	SMOKE DETECTOR C/W SOUNDER BASE & ZENON BEACON
[Symbol]	HEAT DETECTOR
[Symbol]	HEAT DETECTOR C/W SOUNDER BASE & ZENON BEACON
[Symbol]	HEAT DETECTOR C/W SOUNDER BASE
[Symbol]	FIRE ALARM MANUAL CALL POINT (BREAK GLASS)
[Symbol]	INTERFACE UNIT
[Symbol]	FIRE ALARM SOUNDER

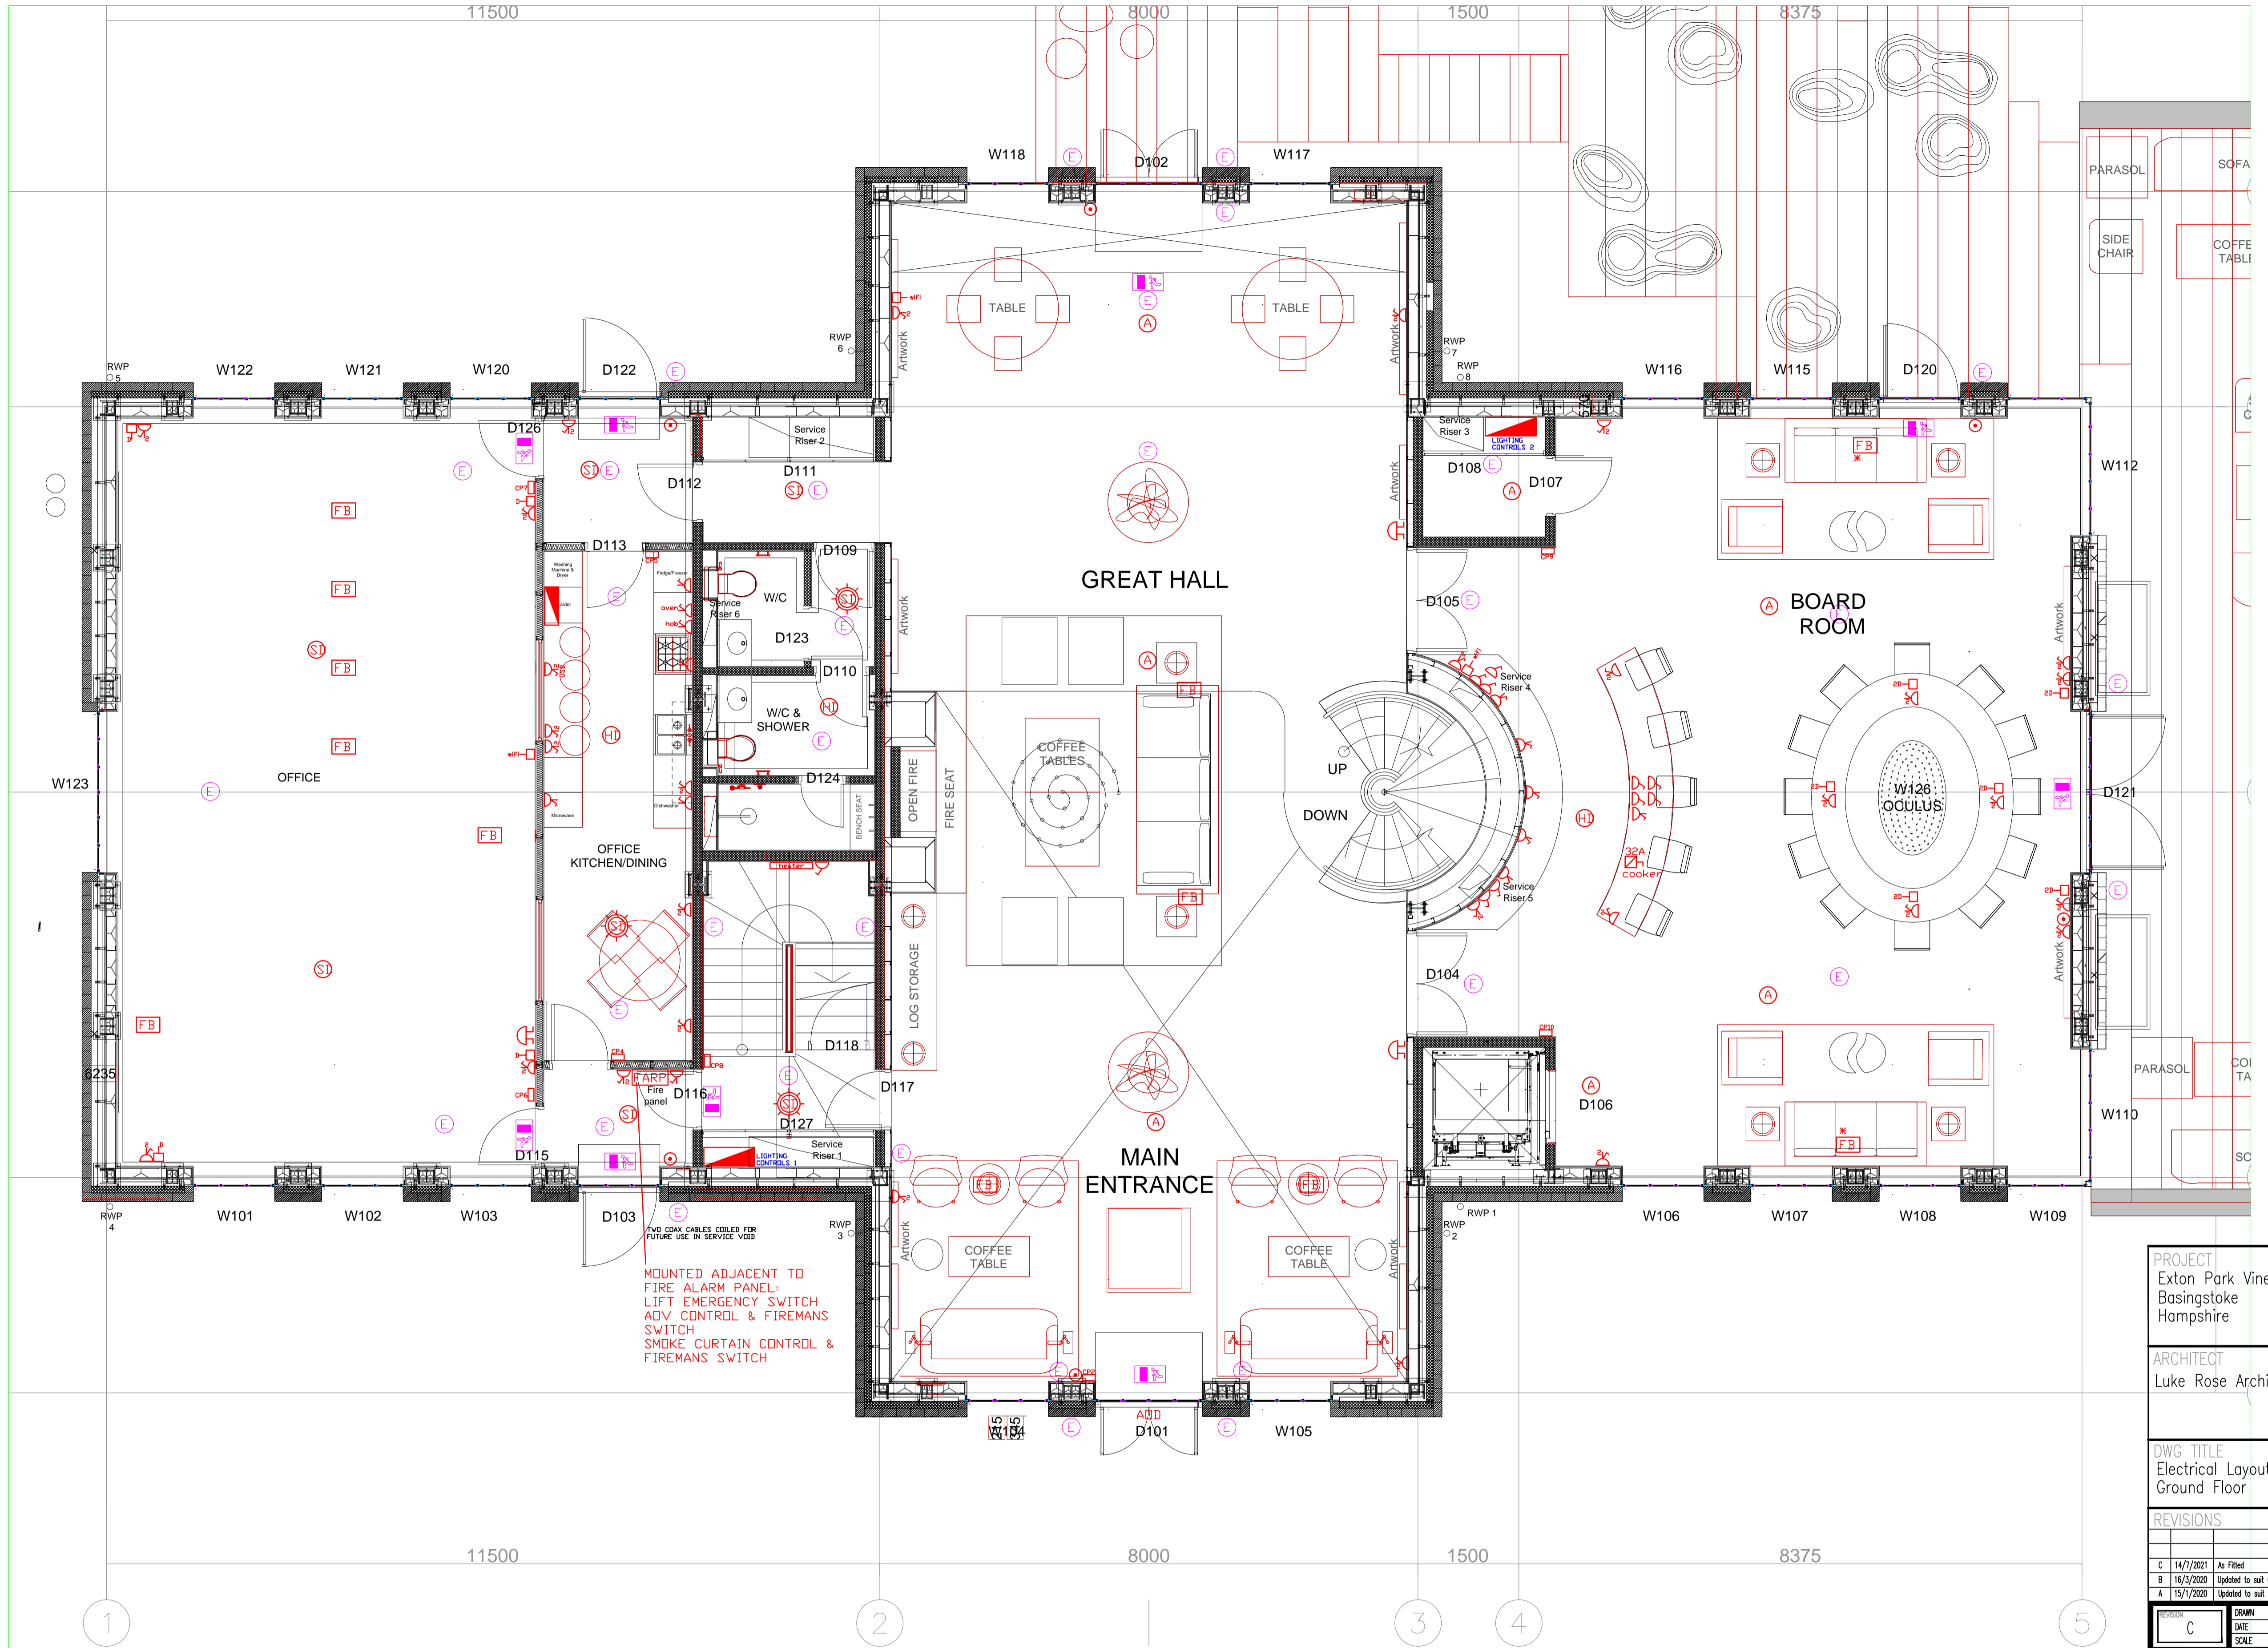

MOUNTED ADJACENT TO FIRE ALARM PANEL:
LIFT EMERGENCY SWITCH
ADV CONTROL & FIREMANS SWITCH
SMOKE CURTAIN CONTROL & FIREMANS SWITCH

PROJECT Exton Park Vineyard Basingstoke Hampshire	
ARCHITECT Luke Rose Architect	
DWG TITLE Electrical Layout Ground Floor	
REVISIONS	
C	14/7/2021 As Filled
B	16/3/2020 Updated to suit Owl lighting & interior designer layout
A	15/1/2020 Updated to suit new building layout
ISSUED BY C	DATE Dec 2018
CHECKED JS	SCALE 1:50 @ A1
35000.2	
Baudelaire Ltd <small>SPECIALISTS IN ELECTRICAL DESIGN & CONTRACTING</small> Unit 7, Prospect Business Centre Prospect Road, Alresford Hants. SO24 9UH Tel: 01962 737020 Fax: 01962 737022 info@baudelaireltd.co.uk www.baudelaireltd.co.uk Established 1976	

POWER	
SYMBOL	DESCRIPTION
[Symbol]	PANEL BOARD
[Symbol]	SUB DISTRIBUTION BOARD
[Symbol]	ISOLATOR SWITCH
[Symbol]	SWITCH FUSE DISCONNECTOR (X DENOTES RATING / SINGLE OR 3 PHASE)
[Symbol]	TWIN SWITCHED SOCKET
[Symbol]	SWITCHED SOCKET OUTLET
[Symbol]	UNSWITCHED SOCKET OUTLET
[Symbol]	SWITCHED FUSED CONNECTION UNIT
[Symbol]	UNSWITCHED FUSED CONNECTION UNIT
[Symbol]	FLEX OUTLET
[Symbol]	KEY SWITCHED FUSED CONNECTION UNIT
[Symbol]	DENOTES NEON INDICATED
[Symbol]	DENOTES COMPLETE WITH FLEX OUTLET
[Symbol]	SHOWER SOCKET
[Symbol]	DOUBLE POLE SWITCH (X DENOTES RATING IN AMPS)
[Symbol]	3 POLE ISOLATOR SWITCH
[Symbol]	FLOOR BOX C/W 1X3G 13A SSO, 2G DATA OUTLET - * denotes *5A
[Symbol]	COOKER CONTROL UNIT
[Symbol]	DATA OUTLET
[Symbol]	LUTRON SLAVE PANEL
FIRE ALARM	
[Symbol]	DOOR HOLD OPEN UNIT
[Symbol]	FIRE ALARM MAIN PANEL
[Symbol]	FIRE ALARM REPEATER PANEL
[Symbol]	SMOKE DETECTOR
[Symbol]	SMOKE DETECTOR C/W SOUNDER BASE
[Symbol]	SMOKE DETECTOR C/W SOUNDER BASE & ZENON BEACON
[Symbol]	HEAT DETECTOR
[Symbol]	HEAT DETECTOR C/W SOUNDER BASE & ZENON BEACON
[Symbol]	HEAT DETECTOR C/W SOUNDER BASE
[Symbol]	FIRE ALARM MANUAL CALL POINT (BREAK GLASS)
[Symbol]	INTERFACE UNIT
[Symbol]	FIRE ALARM SOUNDER

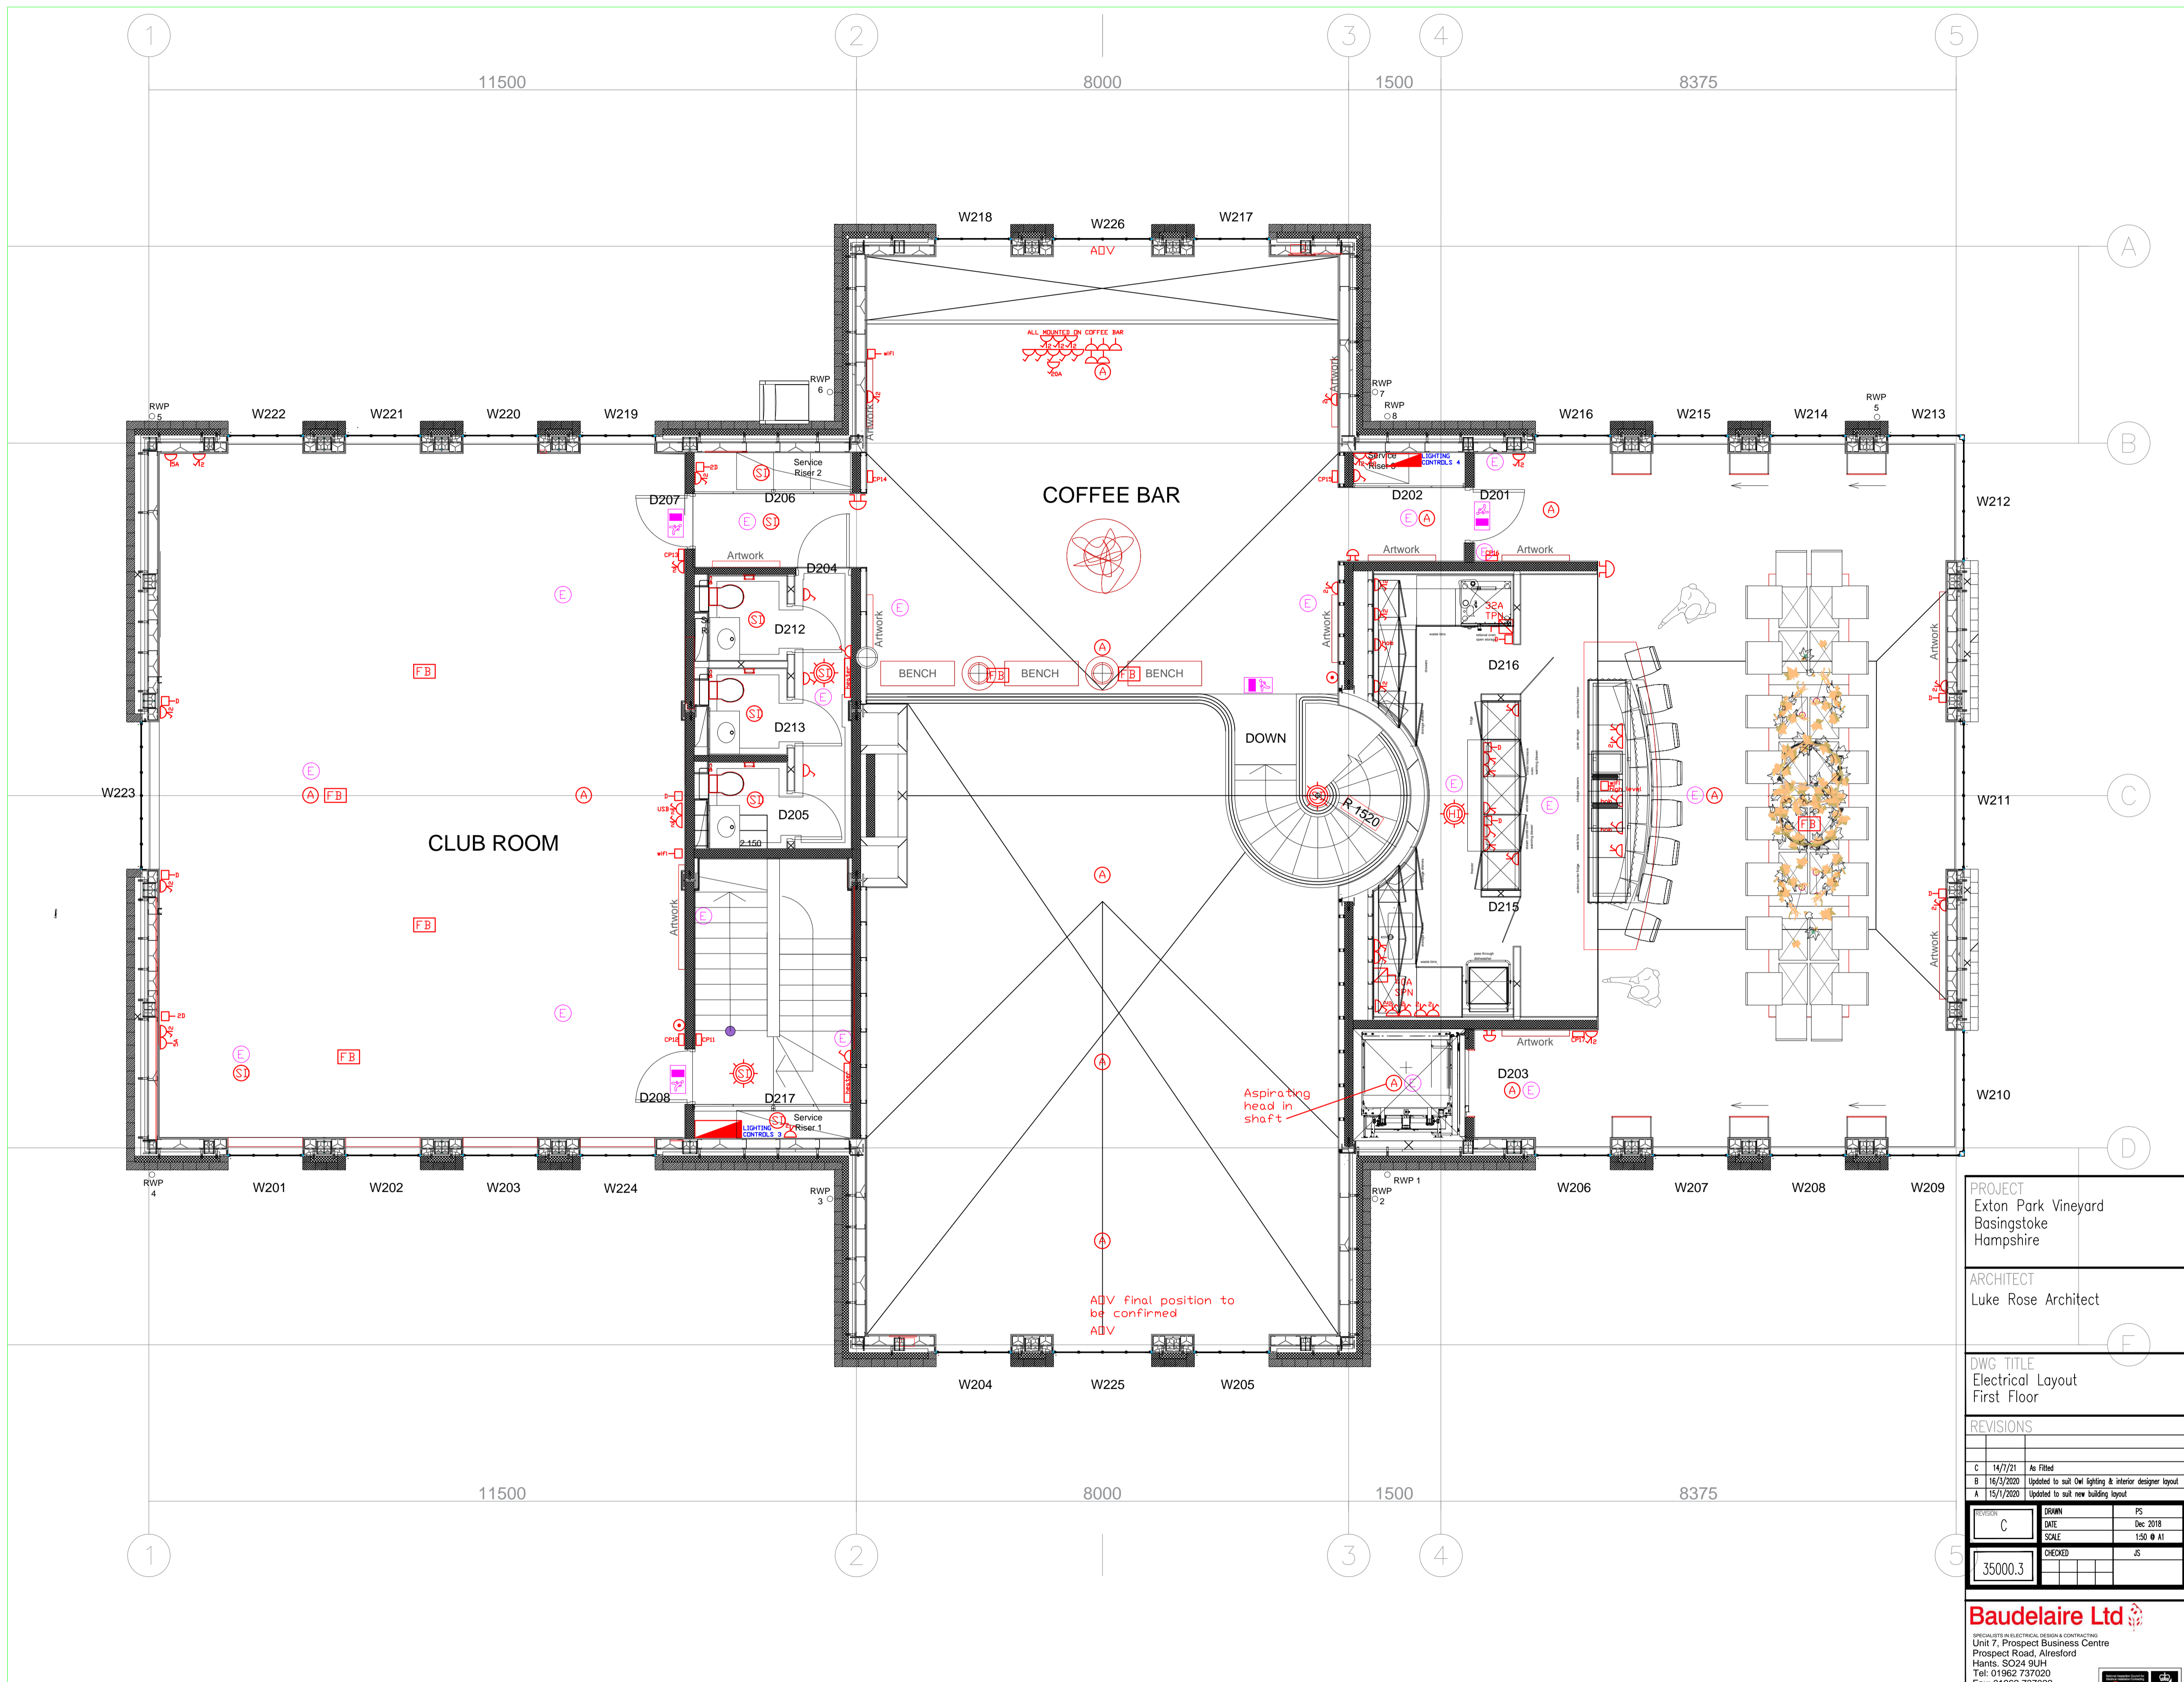

PROJECT
 Exton Park Vineyard
 Basingstoke
 Hampshire

ARCHITECT
 Luke Rose Architect

DWG TITLE
 Electrical Layout
 First Floor

REVISIONS		
C	14/7/21	As Filled
B	16/3/2020	Updated to suit Owl lighting & interior designer layout
A	15/1/2020	Updated to suit new building layout

PROJECT NO	DATE	SCALE
C	Dec. 2018	1:50 @ A1
CHECKED	DATE	BY
35000.3		JS

Baudelaire Ltd
 SPECIALISTS IN ELECTRICAL DESIGN & CONTRACTING
 Unit 7, Prospect Business Centre
 Prospect Road, Alresford
 Hants. SO24 9UH
 Tel: 01962 737020
 Fax: 01962 737022
 info@baudelaireltd.co.uk
 www.baudelaireltd.co.uk
 Established 1976